

ANIMAL RESCUE LEAGUE OF BOSTON

PROJECT 25.01763.01_ANIMAL RESCUE LEAGUE OF BOSTON_EXTERIOR SIGNAGE

SUBMISSION DATE
06/04/2025

REVISION DATE
MM/DD/YYYY



17 Everberg Road, Unit E
Woburn, MA 01801
info@bluebirdgs.com
617.250.8500

FONT

SCALA SANS - CONDENSED BOLD

ABCDEFGHIJKLMNOPQRSTUVWXYZ
abcdefghijklmnopqrstuvwxyz
0123456789!@#\$%^&*()

KERNING: 0; LEADING: 0
SCALA - BOLD

ABCDEFGHIJKLMNOPQRSTUVWXYZ
abcdefghijklmnopqrstuvwxyz
0123456789!@#\$%^&*()

KERNING: 0; LEADING: 0

SIGN FAMILY

BOSTON VETERINARY CARE

ST - A
QTY - 1
PAGE - 1.0-1.5

ANIMAL RESCUE LEAGUE OF BOSTON

ST - B
QTY - 1
PAGE - 2.0-2.5

ANIMAL RESCUE LEAGUE OF BOSTON

ST - C
QTY - 1
PAGE - 3.0-3.5

ANIMAL RESCUE LEAGUE OF BOSTON

ST - D
QTY - 1
PAGE - 4.0-4.5



ST - E
QTY - 1
PAGE - 5.0-5.3



ST - F
QTY - 2
PAGE - 6.0-6.1



BLUEBIRD
GRAPHIC SOLUTIONS

17 Everberg Road, Unit E
Woburn, MA 01801

info@bluebirdgs.com
617.250.8500

CLIENT
ANIMAL RESCUE LEAGUE

ADDRESS
10 CHANDLER ST
BOSTON, MA 02116

PROJECT
EXTERIOR LETTERS

JOB #
PROJ-25.01763.01


SUBMISSION DATE
06/04/2025

REVISION DATE
MM/DD/YYYY

DESIGNER: K. WHITE
PM: A. MORRISON

SIGN TYPE	DRAWING
—	0.1

SITE PLAN

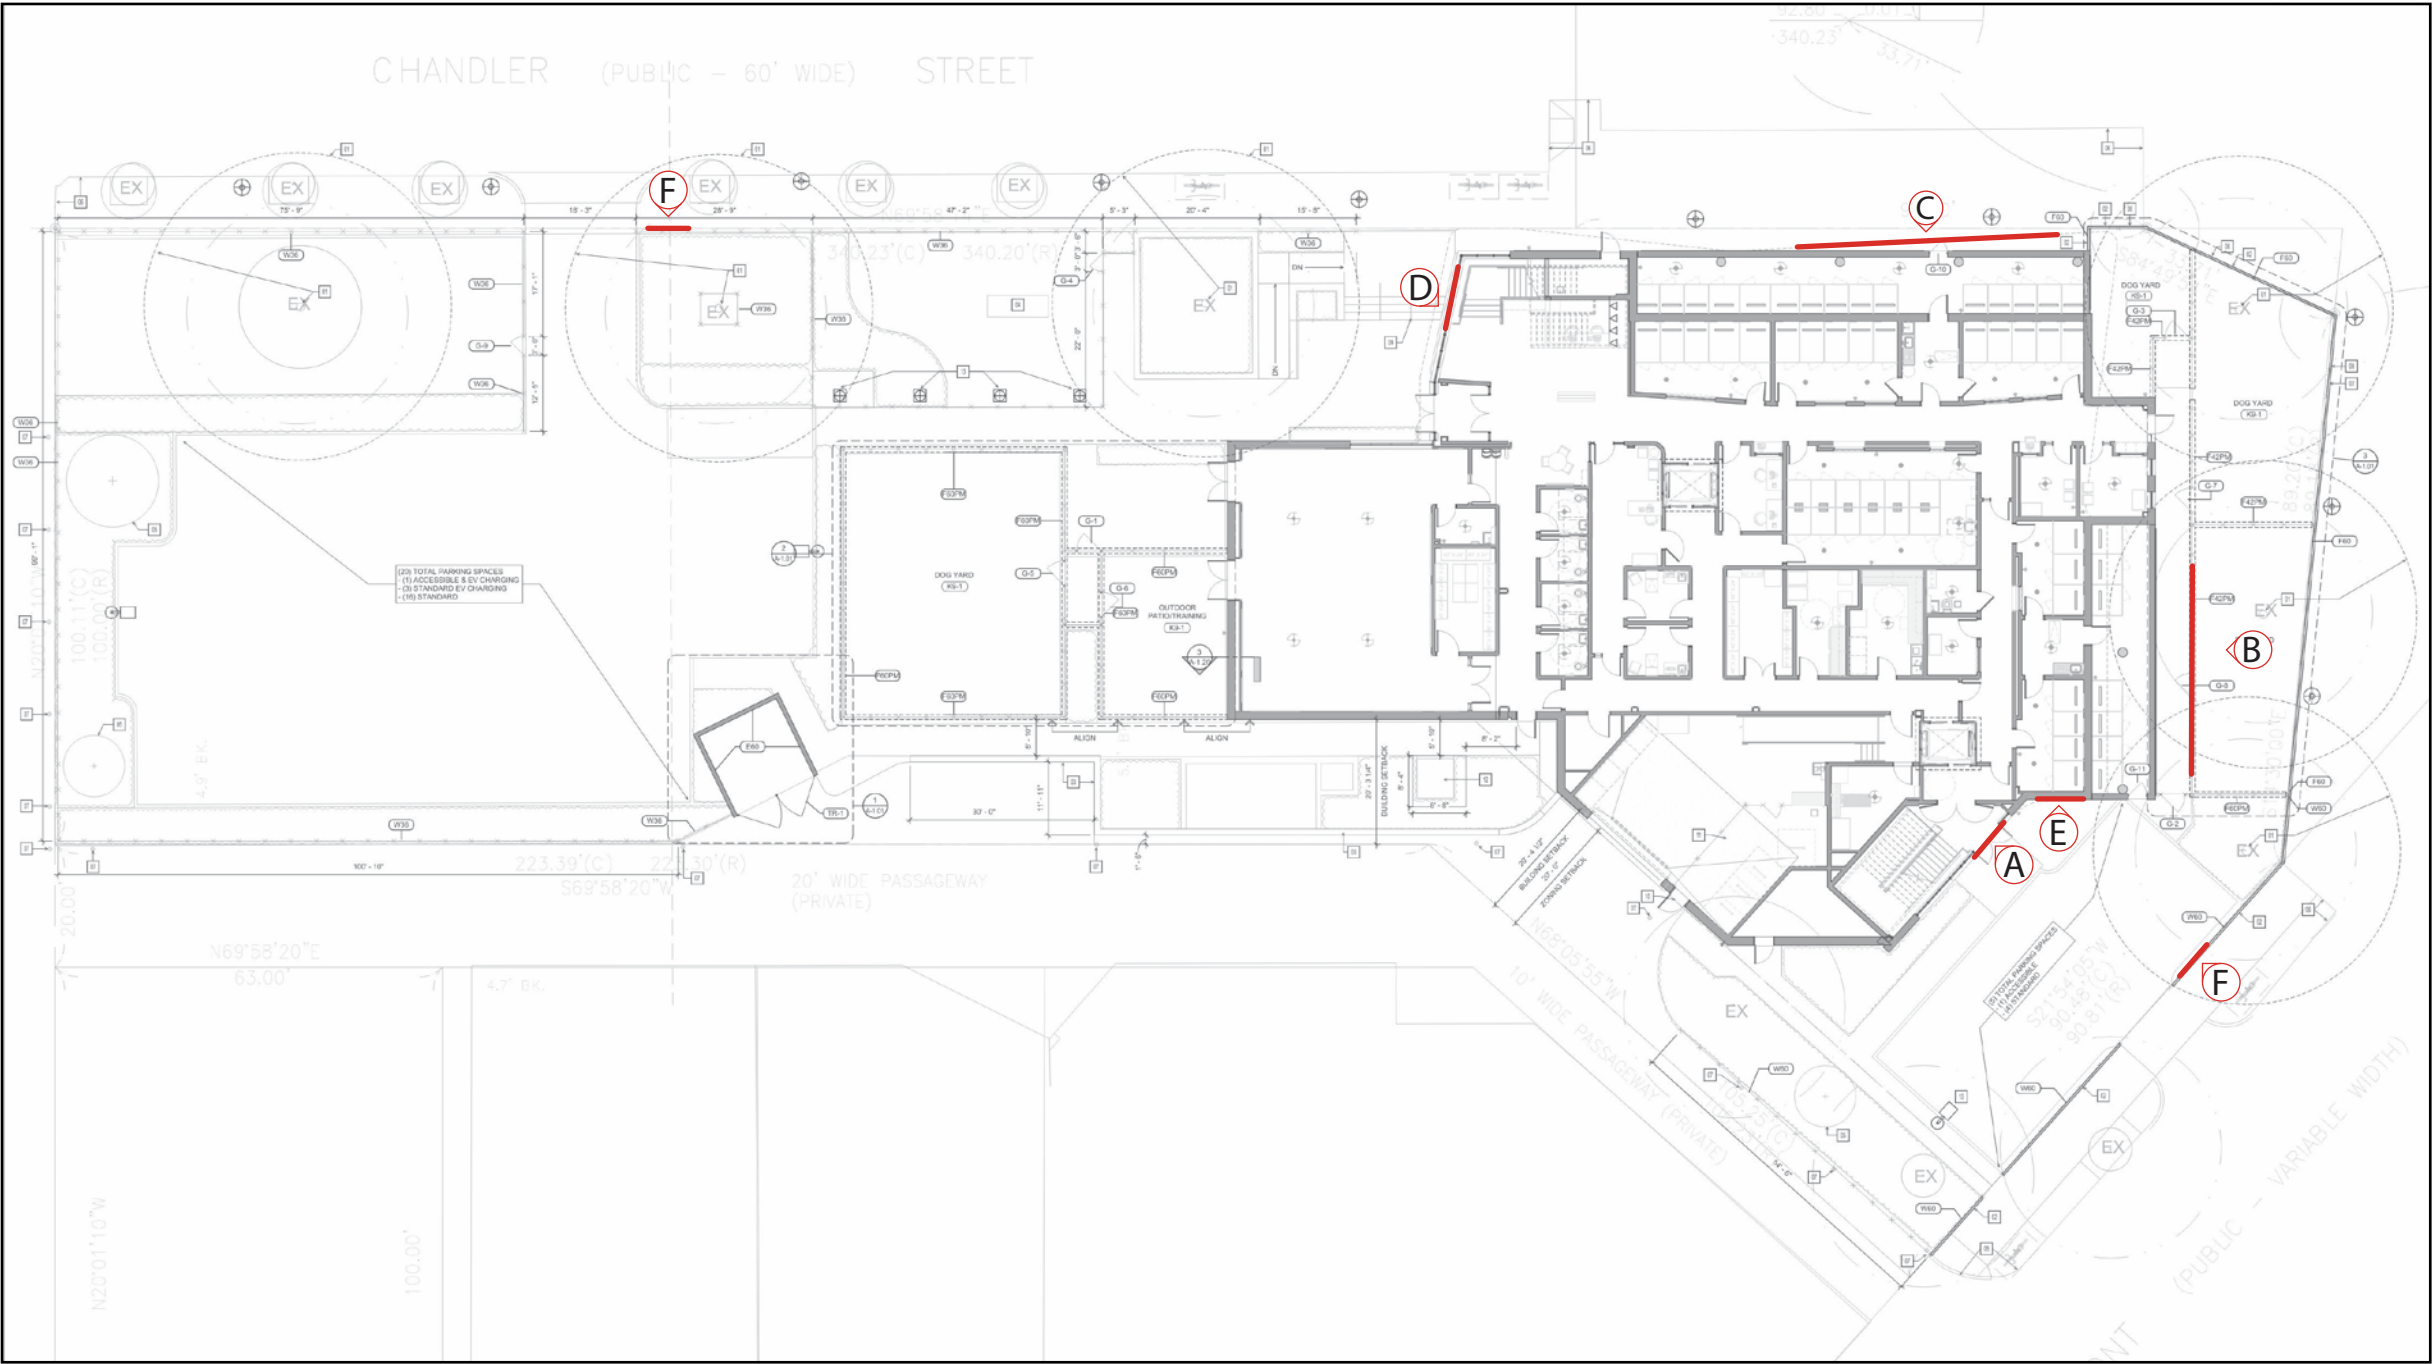

BLUEBIRD
GRAPHIC SOLUTIONS

17 Everberg Road, Unit E
Woburn, MA 01801

info@bluebirdgs.com
617.250.8500

CLIENT
ANIMAL RESCUE LEAGUE

ADDRESS
10 CHANDLER ST
BOSTON, MA 02116

PROJECT
EXTERIOR LETTERS

JOB #
PROJ-25.01763.01

SUBMISSION DATE
06/04/2025

REVISION DATE
MM/DD/YYYY

DESIGNER: K. WHITE
PM: A. MORRISON

SIGN TYPE	DRAWING
—	0.2



BLUEBIRD
GRAPHIC SOLUTIONS

17 Everberg Road, Unit E
Woburn, MA 01801

info@bluebirdgs.com
617.250.8500

CLIENT
ANIMAL RESCUE LEAGUE

ADDRESS
10 CHANDLER ST
BOSTON, MA 02116

PROJECT
EXTERIOR LETTERS

JOB #
PROJ-25.01763.01

SUBMISSION DATE
06/04/2025

REVISION DATE
MM/DD/YYYY



01
1.3

1 3/8" deep fabricated face lit can letters,
face painted to match 120 white,
returns painted to match "Cardinal
Red" PMS 485C

Tube for extending LED light bar,
painted to match existing canopy



01 | SOUTHEAST ELEVATION - FACE LIT LETTERS
1/8" = 1'-0"


**NOTE: TOTAL BUILDING ELEVATION
FRONTAGE EQUAL TO APPROXIMATELY 505",
SIGN TO OCCUPY APPROXIMATELY 158"**

SIGN TYPE A - BOSTON VET SIGN FACE LIT OPTION


Quantity (1)

PALETTE

-  PAINT: TO MATCH 120 WHITE
-  PAINT: TO MATCH CARDINAL RED (PMS 485C)

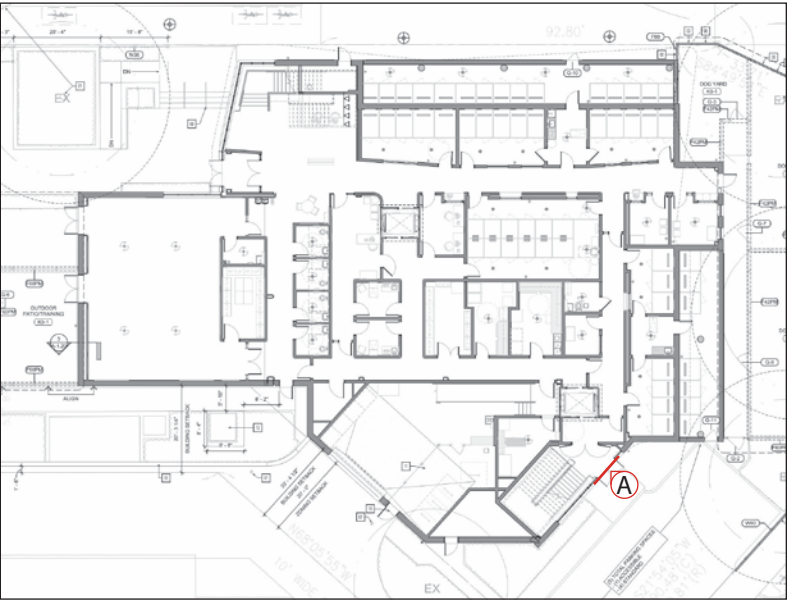


02 | SITE PLAN
NTS

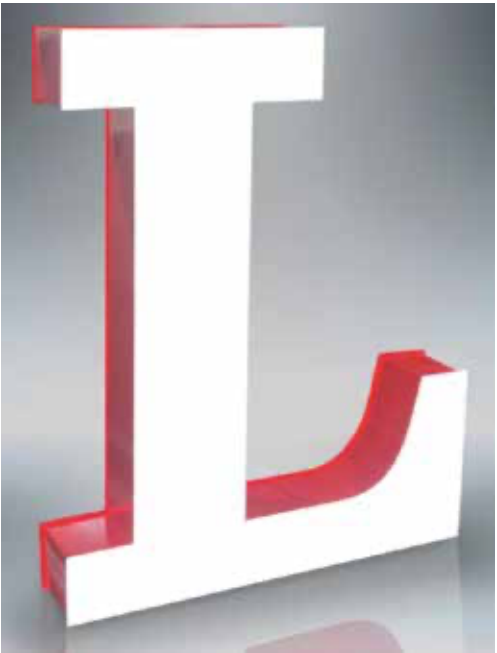


03 | FACE LIT LETTER EXAMPLE
NTS

DESIGNER: K. WHITE
PM: A. MORRISON

SIGN TYPE	DRAWING
A	1.4

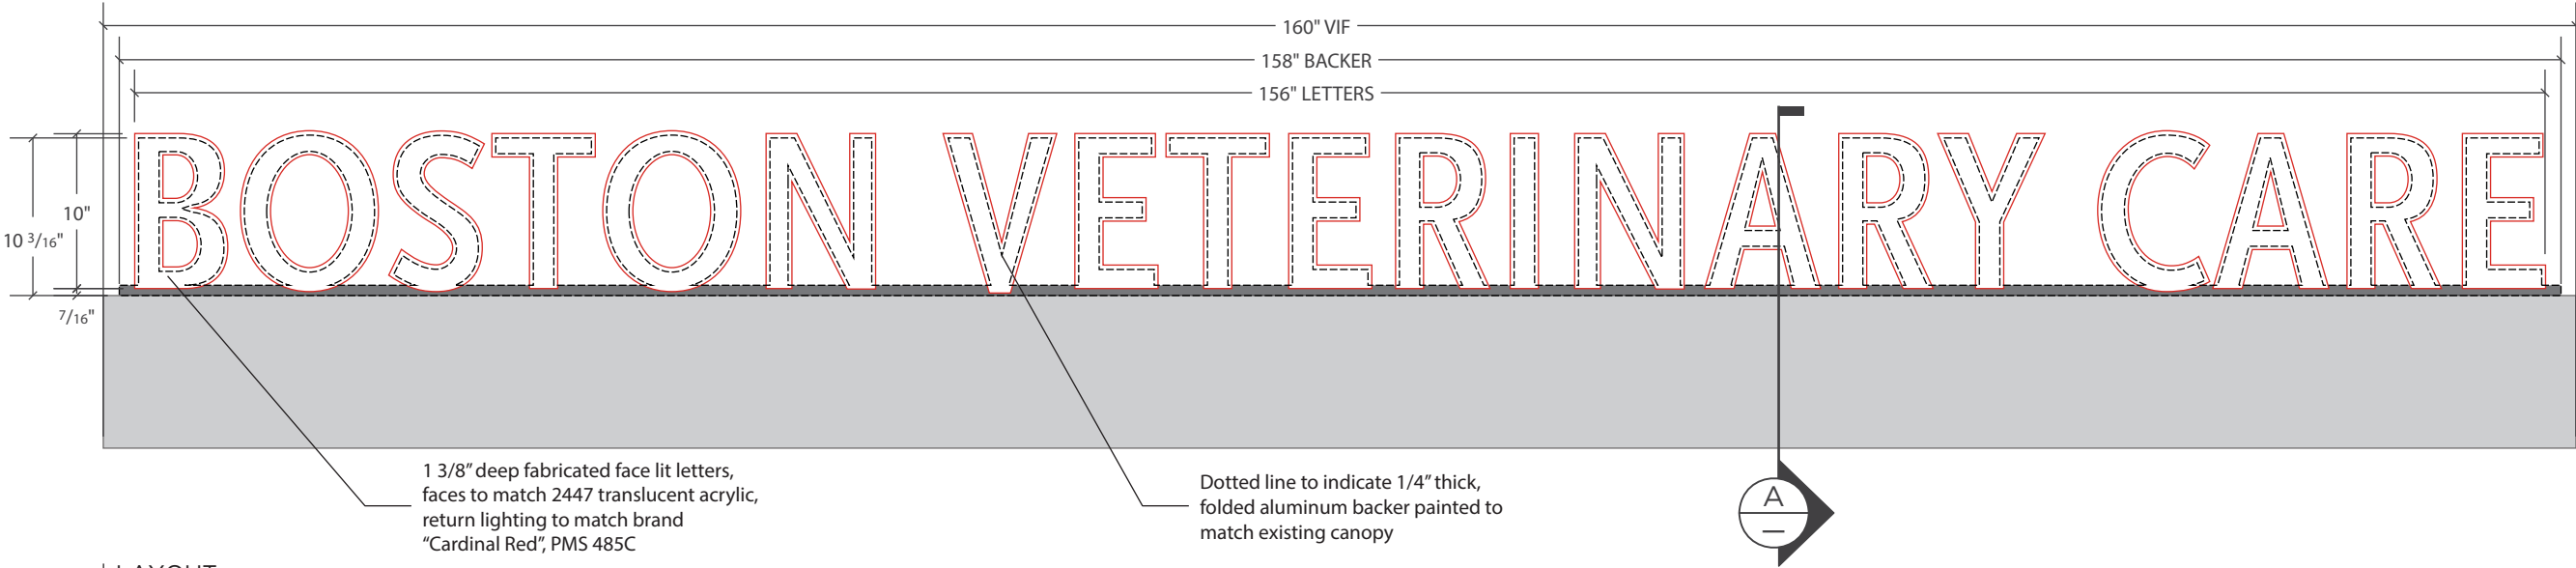

01 | LAYOUT
1" = 1'-0"

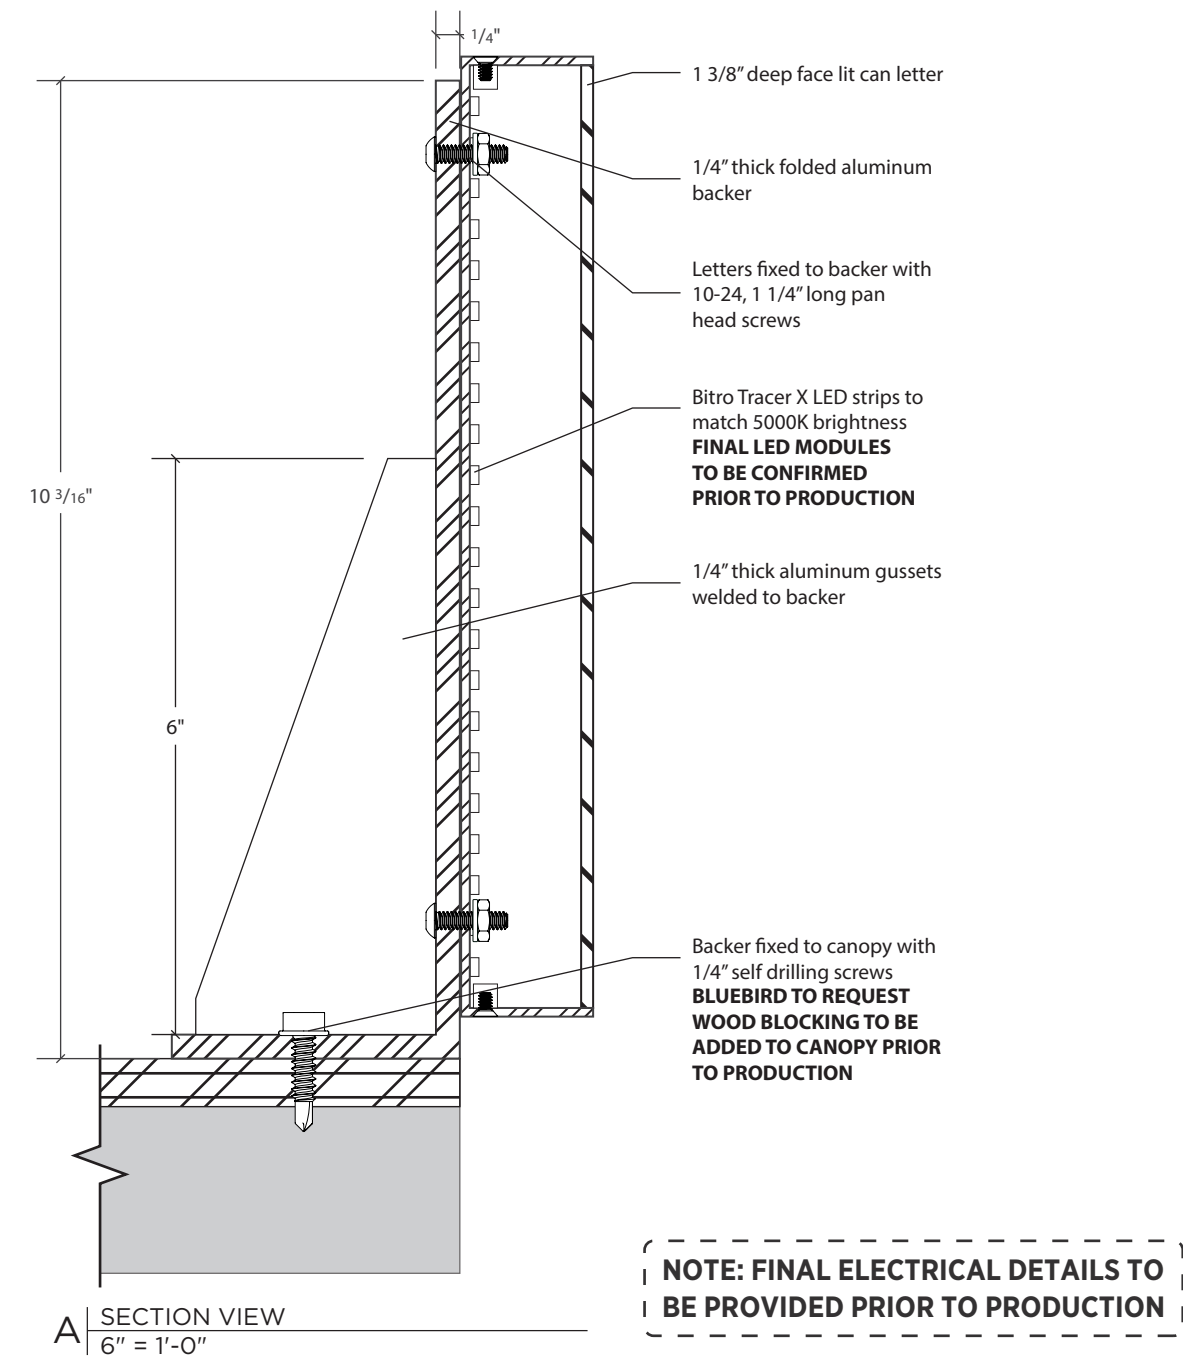

A | SECTION VIEW
6" = 1'-0"



02 | DAY VIEW RENDERING
NTS



03 | NIGHT VIEW RENDERING
NTS



BLUEBIRD
GRAPHIC SOLUTIONS

17 Everberg Road, Unit E
Woburn, MA 01801

info@bluebirdgs.com
617.250.8500

CLIENT
ANIMAL RESCUE LEAGUE

ADDRESS
10 CHANDLER ST
BOSTON, MA 02116

PROJECT
EXTERIOR LETTERS

JOB #
PROJ-25.01763.01

SUBMISSION DATE
06/04/2025

REVISION DATE
MM/DD/YYYY

DESIGNER: K. WHITE
PM: A. MORRISON

SIGN TYPE	DRAWING
A	1.5



BLUEBIRD
GRAPHIC SOLUTIONS

17 Everberg Road, Unit E
Woburn, MA 01801

info@bluebirdgs.com
617.250.8500

CLIENT
ANIMAL RESCUE LEAGUE

ADDRESS
10 CHANDLER ST
BOSTON, MA 02116

PROJECT
EXTERIOR LETTERS

JOB #
PROJ-25.01763.01

SUBMISSION DATE
06/04/2025

REVISION DATE
MM/DD/YYYY



01
2.2

3 5/8" deep fabricated
face lit can letters, face
painted to match 120
white, returns painted
to match "Cardinal Red"
PMS 485C



01 | EAST ELEVATION - FACE LIT LETTERS
1/8" = 1'-0"


**NOTE: TOTAL BUILDING ELEVATION
FRONTAGE EQUAL TO APPROXIMATELY 1,110",
SIGN TO OCCUPY APPROXIMATELY 465"**

SIGN TYPE B - ARL SIGN 1 FACE LIT OPTION


Quantity (1)

PALETTE

-  PAINT: TO MATCH 120 WHITE
-  PAINT: TO MATCH CARDINAL RED (PMS 485C)

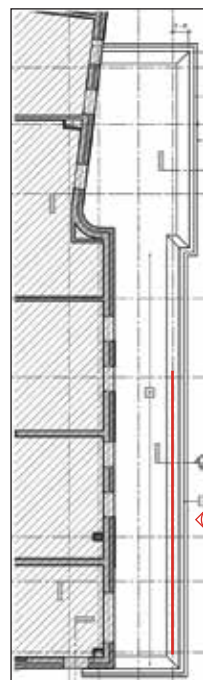


02 | SITE PLAN
NTS

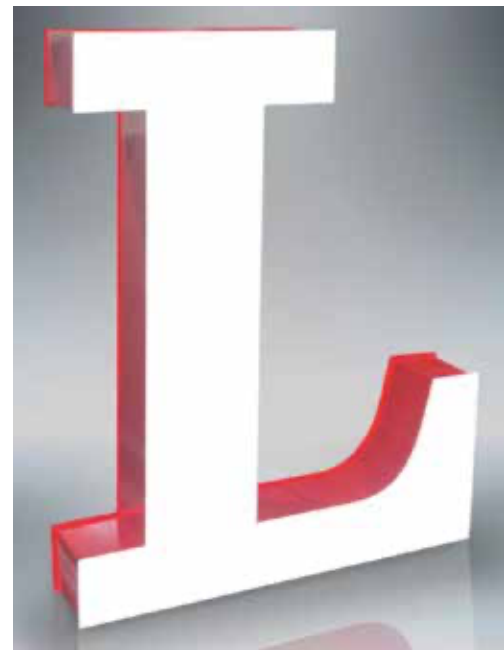

03 | FACE LIT LETTER EXAMPLE
NTS

DESIGNER: K. WHITE
PM: A. MORRISON


SIGN TYPE	DRAWING
B	2.4

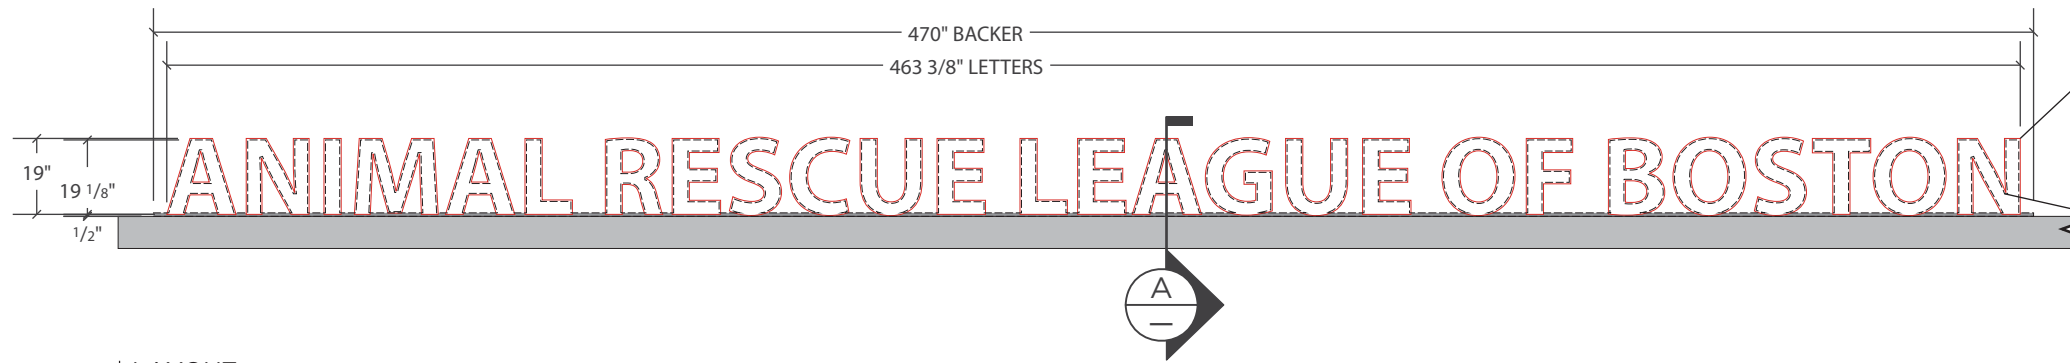

3 5/8" deep fabricated face lit letters, faces to match 2447 translucent acrylic, returns painted to match brand "Cardinal Red", PMS 485C

Dotted line to indicate 1/4" thick, folded aluminum backer painted to match existing canopy

01 | LAYOUT
1/4" = 1'-0"

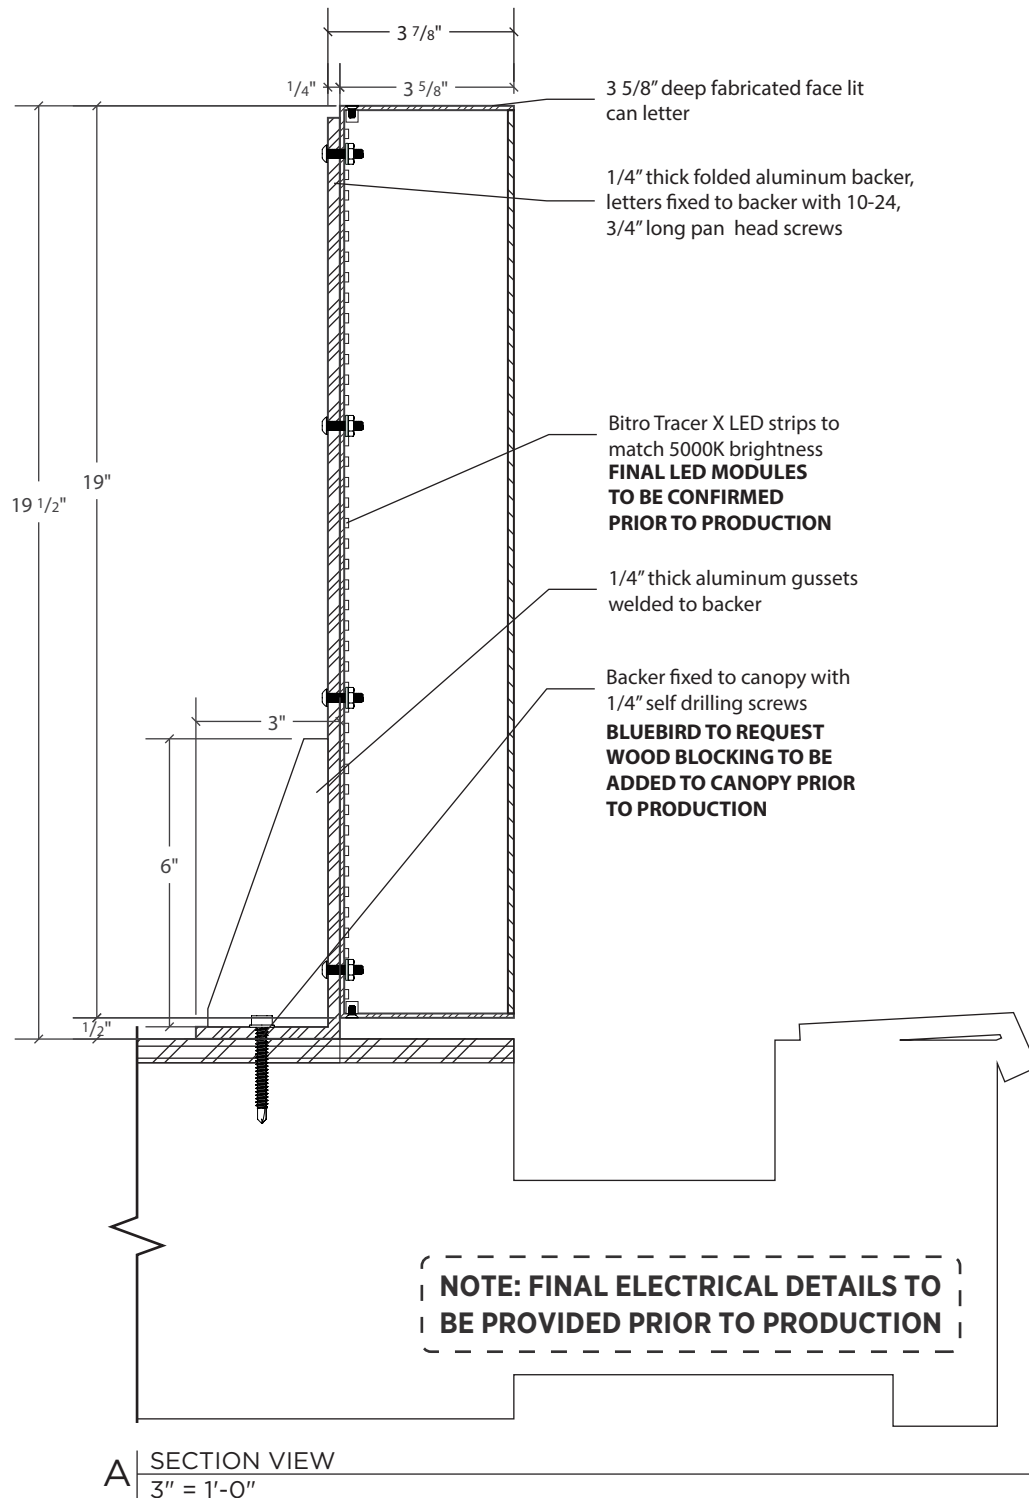

A | SECTION VIEW
3" = 1'-0"



02 | DAY VIEW RENDERING
NTS



03 | NIGHT VIEW RENDERING
NTS



BLUEBIRD
GRAPHIC SOLUTIONS

17 Everberg Road, Unit E
Woburn, MA 01801

info@bluebirdgs.com
617.250.8500

CLIENT
ANIMAL RESCUE LEAGUE

ADDRESS
10 CHANDLER ST
BOSTON, MA 02116

PROJECT
EXTERIOR LETTERS

JOB #
PROJ-25.01763.01

SUBMISSION DATE
06/04/2025

REVISION DATE
MM/DD/YYYY

DESIGNER: K. WHITE
PM: A. MORRISON

SIGN TYPE	DRAWING
B	2.5



BLUEBIRD
GRAPHIC SOLUTIONS

17 Everberg Road, Unit E
Woburn, MA 01801

info@bluebirdgs.com
617.250.8500

CLIENT
ANIMAL RESCUE LEAGUE

ADDRESS
10 CHANDLER ST
BOSTON, MA 02116

PROJECT
EXTERIOR LETTERS

JOB #
PROJ-25.01763.01

SUBMISSION DATE
06/04/2025

REVISION DATE
MM/DD/YYYY





01 | NORTH ELEVATION - FACE LIT LETTERS
1/8" = 1'-0"


**NOTE: TOTAL BUILDING ELEVATION
FRONTAGE EQUAL TO APPROXIMATELY 1,168",
SIGN TO OCCUPY APPROXIMATELY 558"**

SIGN TYPE C - ARL SIGN 2 FACE LIT OPTION


Quantity (1)

PALETTE

-  PAINT: TO MATCH 120 WHITE
-  PAINT: TO MATCH CARDINAL RED (PMS 485C)

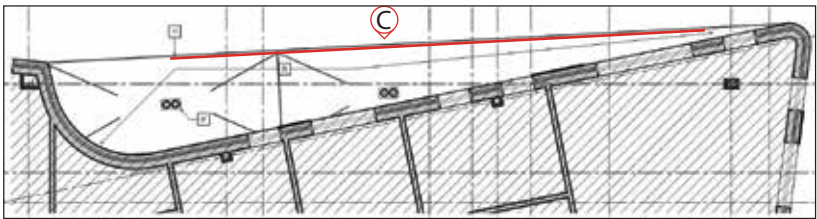


02 | SITE PLAN
NTS

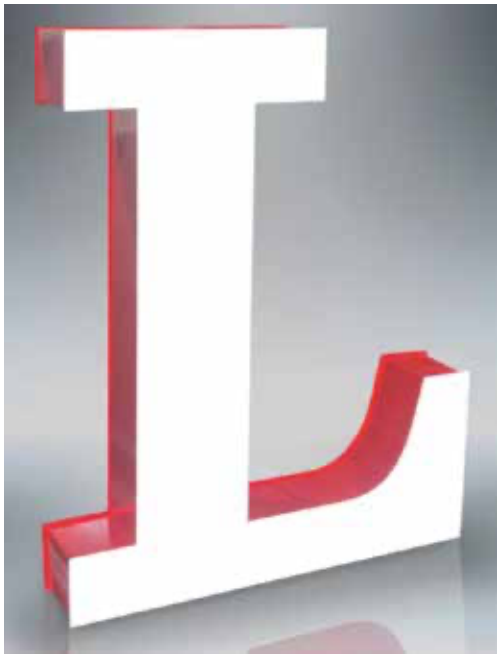

03 | FACE LIT LETTER EXAMPLE
NTS

DESIGNER: K. WHITE
PM: A. MORRISON

SIGN TYPE	DRAWING
C	3.4

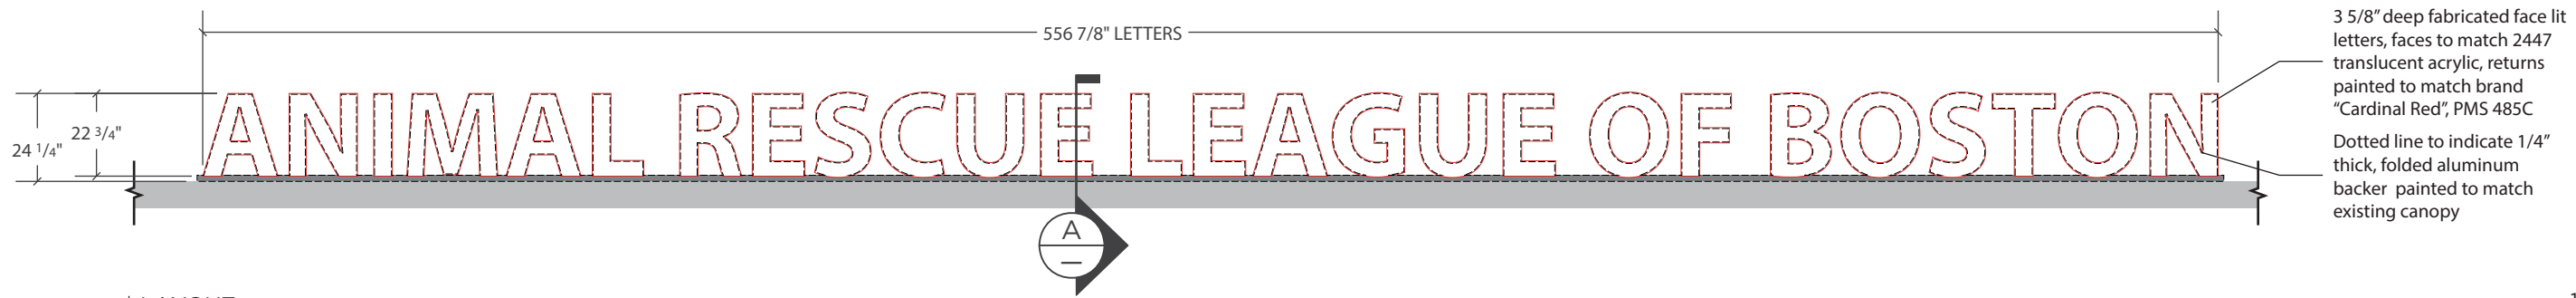

17 Everberg Road, Unit E
Woburn, MA 01801

info@bluebirdgs.com
617.250.8500

CLIENT
ANIMAL RESCUE LEAGUE


ADDRESS
10 CHANDLER ST
BOSTON, MA 02116

PROJECT
EXTERIOR LETTERS

JOB #
PROJ-25.01763.01

SUBMISSION DATE
06/04/2025

REVISION DATE
MM/DD/YYYY

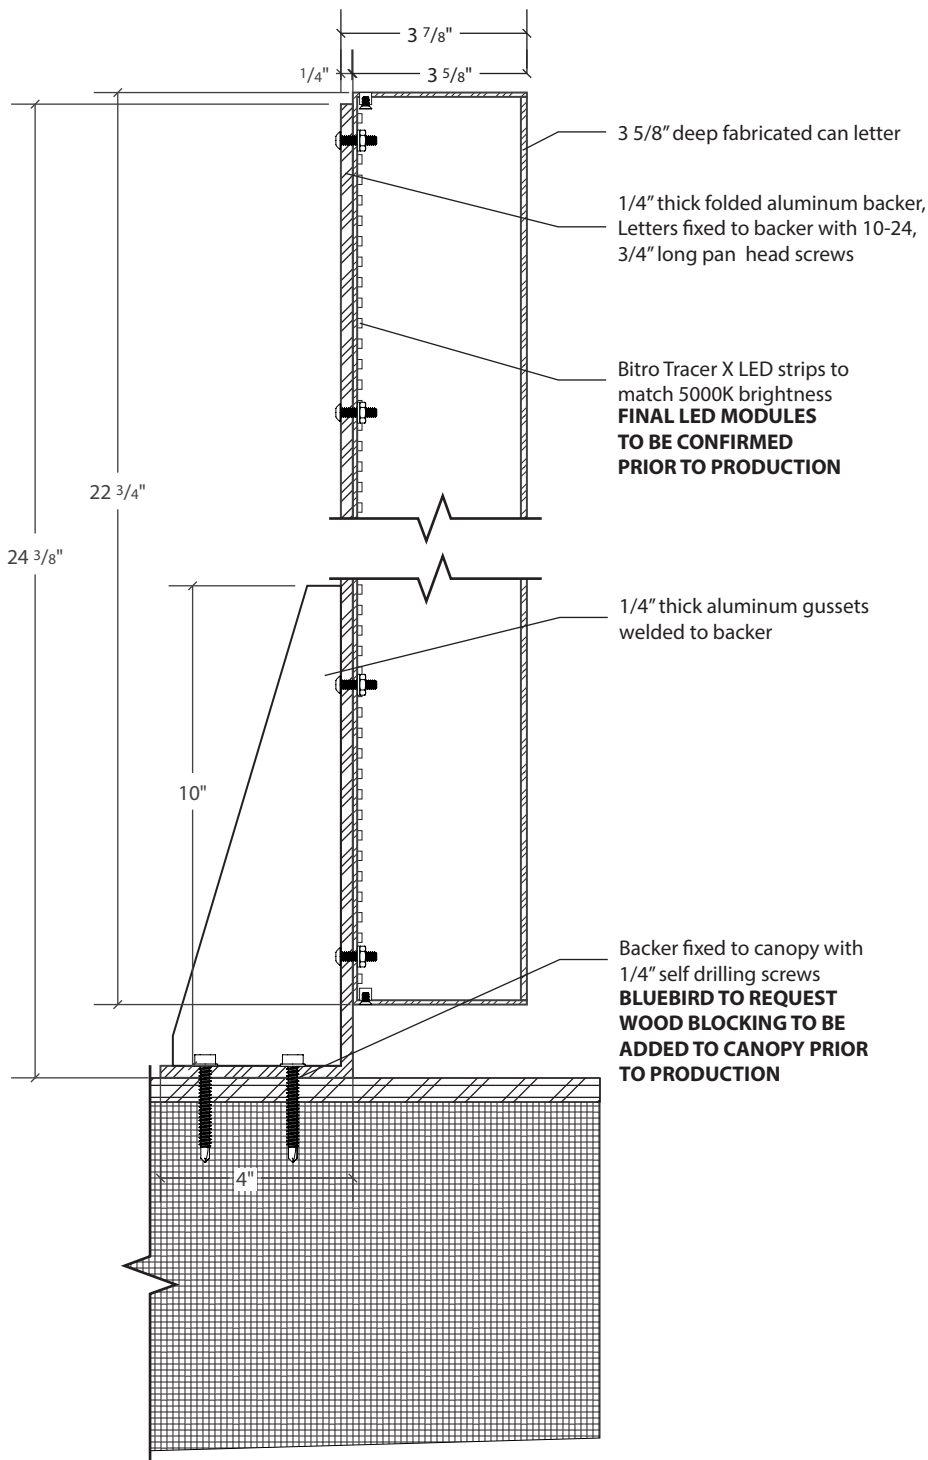

02 DAY VIEW RENDERING
NTS



03 NIGHT VIEW RENDERING
NTS

NOTE: FINAL ELECTRICAL DETAILS TO BE PROVIDED PRIOR TO PRODUCTION

DESIGNER: K. WHITE
PM: A. MORRISON

SIGN TYPE	DRAWING
C	3.5



BLUEBIRD
GRAPHIC SOLUTIONS

17 Everberg Road, Unit E
Woburn, MA 01801

info@bluebirdgs.com
617.250.8500

CLIENT
ANIMAL RESCUE LEAGUE

ADDRESS
10 CHANDLER ST
BOSTON, MA 02116

PROJECT
EXTERIOR LETTERS

JOB #
PROJ-25.01763.01

SUBMISSION DATE
06/04/2025

REVISION DATE
MM/DD/YYYY



01
4.1

Boca Nanolume LED
light bar fixed to existing
canopy with Boca track
mount system

1 3/8" deep fabricated
face lit can letters, face
painted to match 120
white, returns painted
to match "Cardinal Red"
PMS 485C

01 | WEST ELEVATION - EDGE LIT LETTERS
1/8" = 1'-0"

**NOTE: TOTAL BUILDING ELEVATION
FRONTAGE EQUAL TO APPROXIMATELY 435",
SIGN TO OCCUPY APPROXIMATELY 192"**


SIGN TYPE D - ARL SIGN 3 FACE LIT OPTION

Quantity (1)

PALETTE

 PAINT: TO MATCH 120 WHITE




 PAINT: TO MATCH CARDINAL RED (PMS 485C)

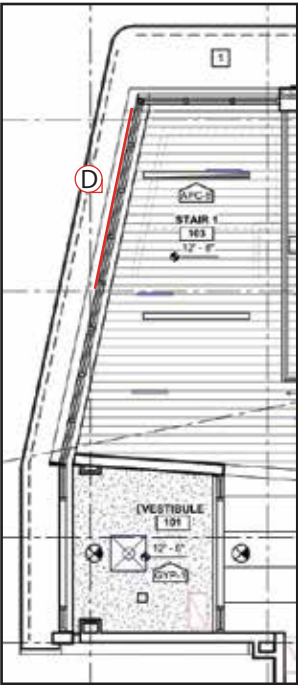

02 | SITE PLAN
NTS

DESIGNER: K. WHITE
PM: A. MORRISON



SIGN TYPE	DRAWING
D	4.4

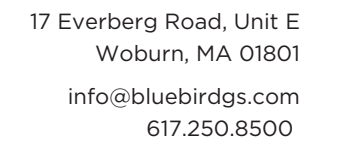  

REVISION DATE
MM/DD/YYYY

DESIGNER: K. WHITE
PM: A. MORRISON

SIGN TYPE	DRAWING
D	4.5

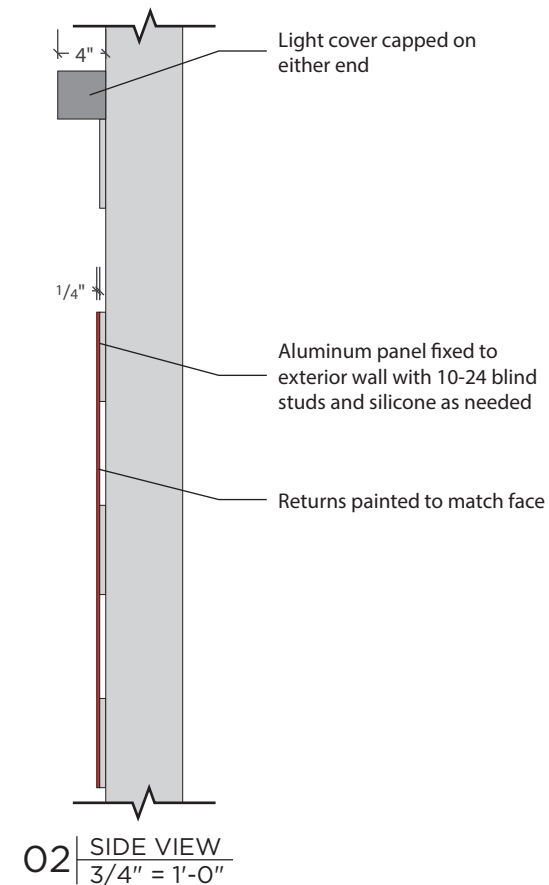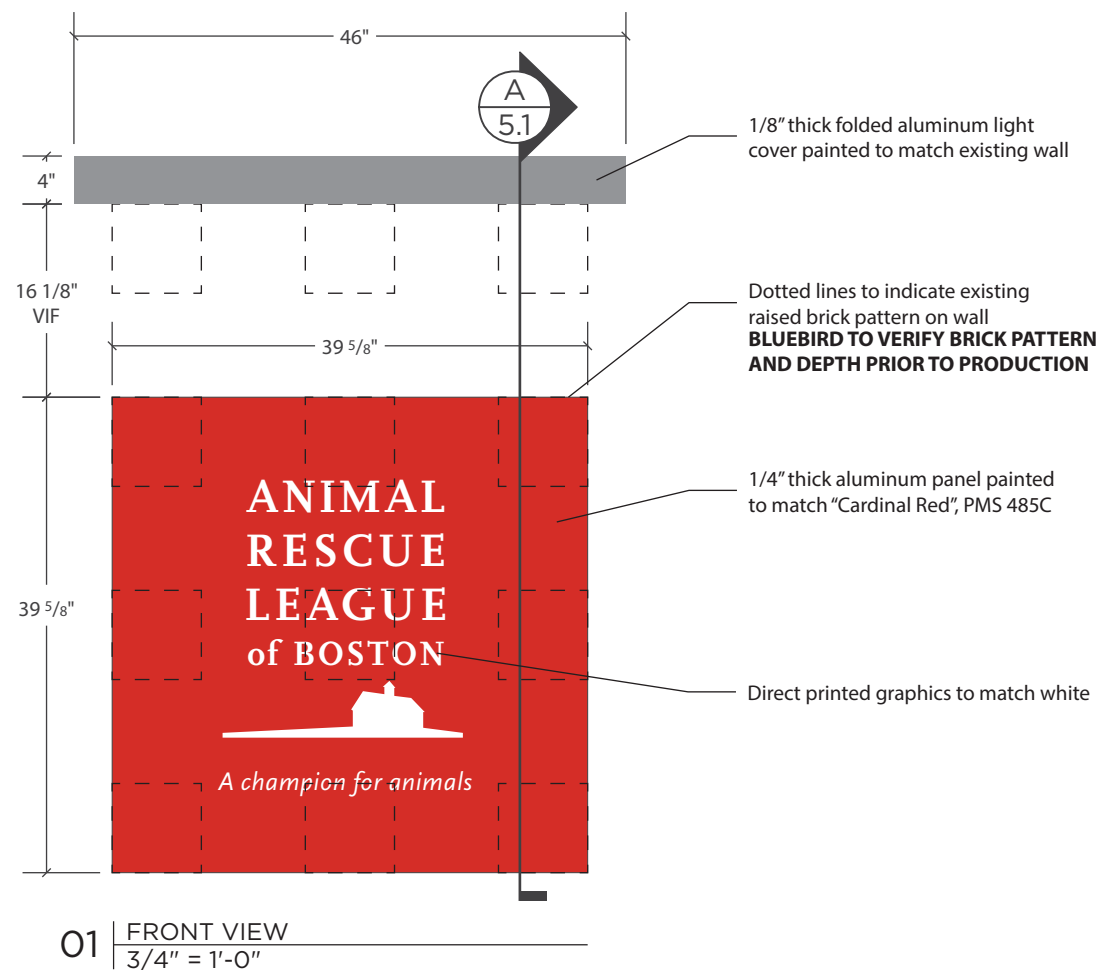




NOTES: BLUEBIRD TO VERIFY INSTALL LOCATION PRIOR TO PRODUCTION, PLEASE CONFIRM ELEVATION

SIGN TYPE E - ENTRY WALL SIGN

Quantity (1)

PALETTE

-  PRINT: TO MATCH WHITE
-  PAINT: TO MATCH CARDINAL RED (PMS 485C)

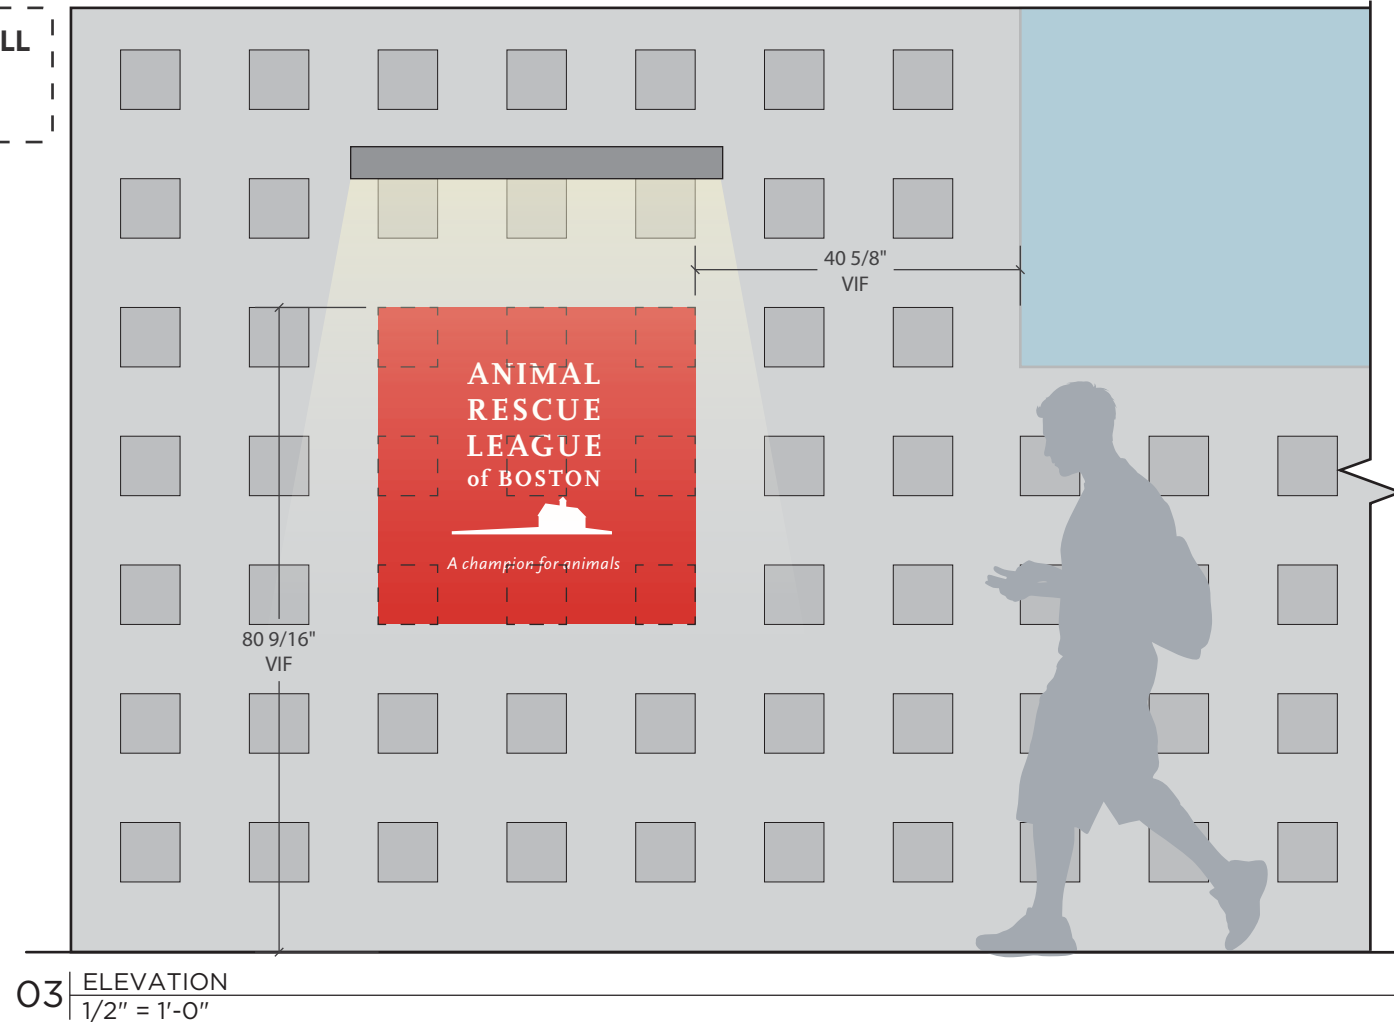

BLUEBIRD
GRAPHIC SOLUTIONS

17 Everberg Road, Unit E
Woburn, MA 01801

info@bluebirdgs.com
617.250.8500

CLIENT
ANIMAL RESCUE LEAGUE

ADDRESS
10 CHANDLER ST
BOSTON, MA 02116

PROJECT
EXTERIOR LETTERS




JOB #
PROJ-25.01763.01

SUBMISSION DATE
06/04/2025

REVISION DATE
MM/DD/YYYY

DESIGNER: K. WHITE
PM: A. MORRISON

SIGN TYPE	DRAWING
E	5.0

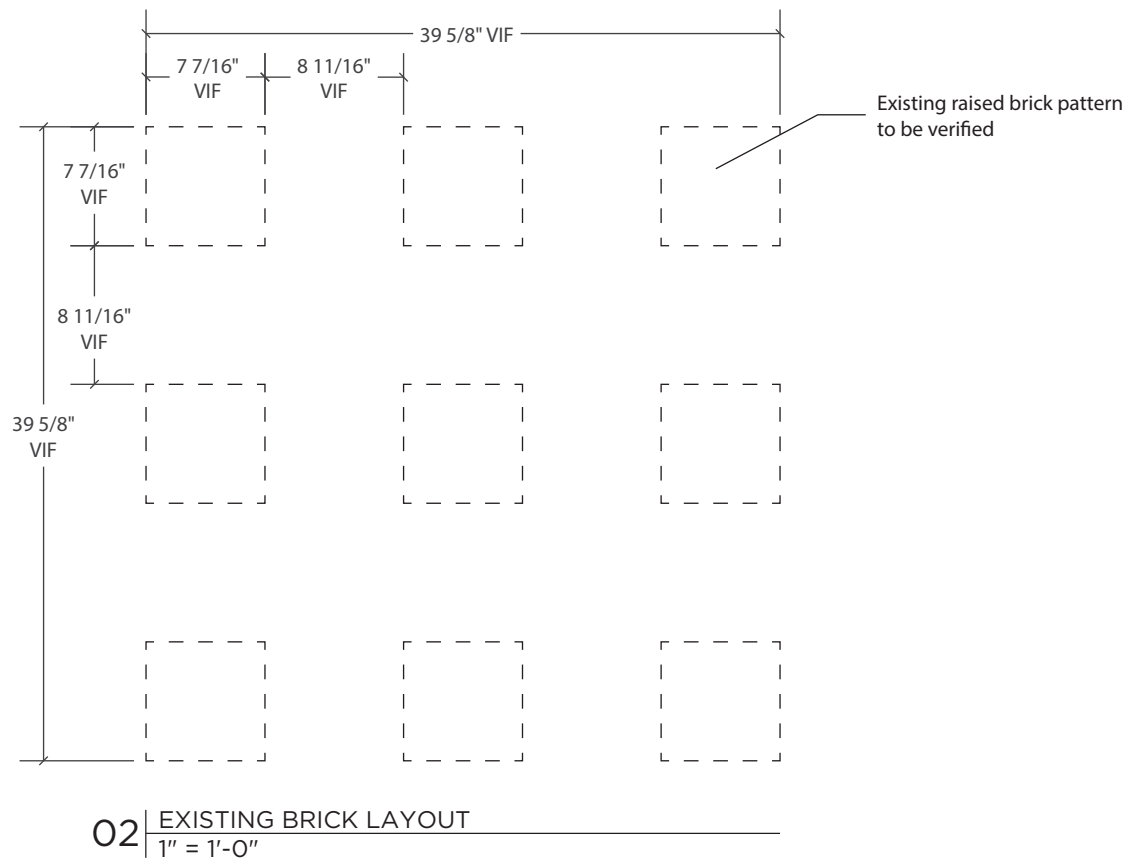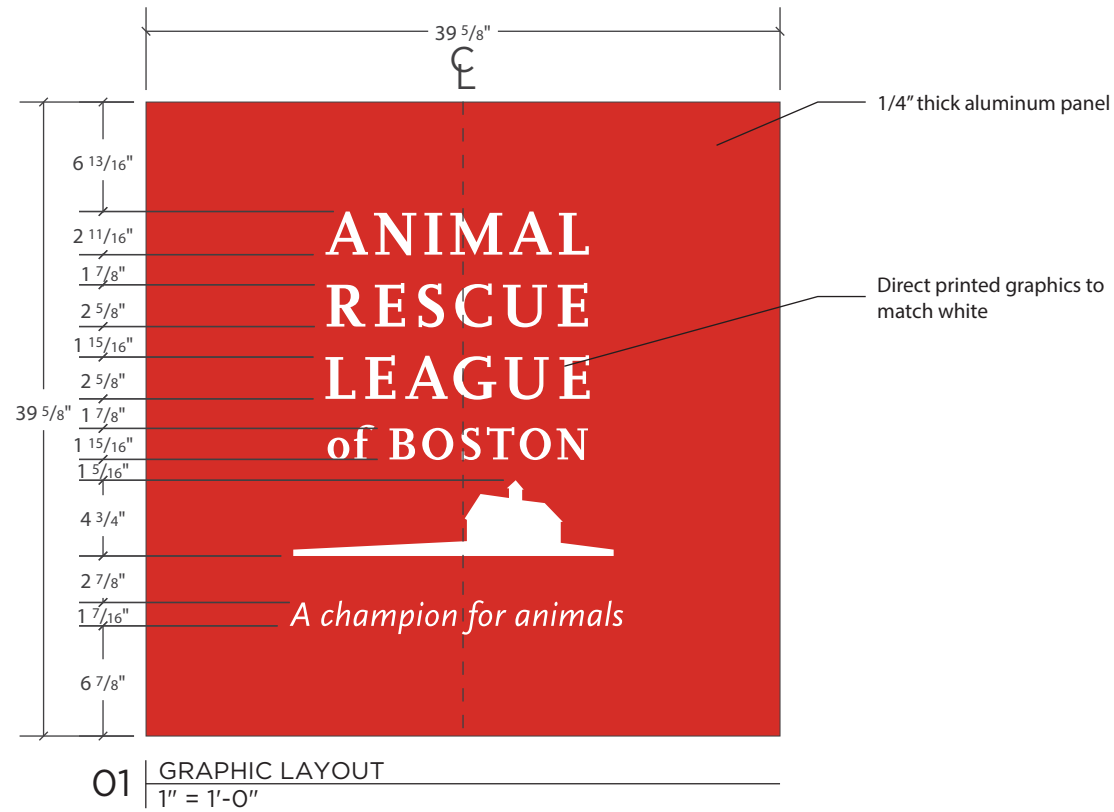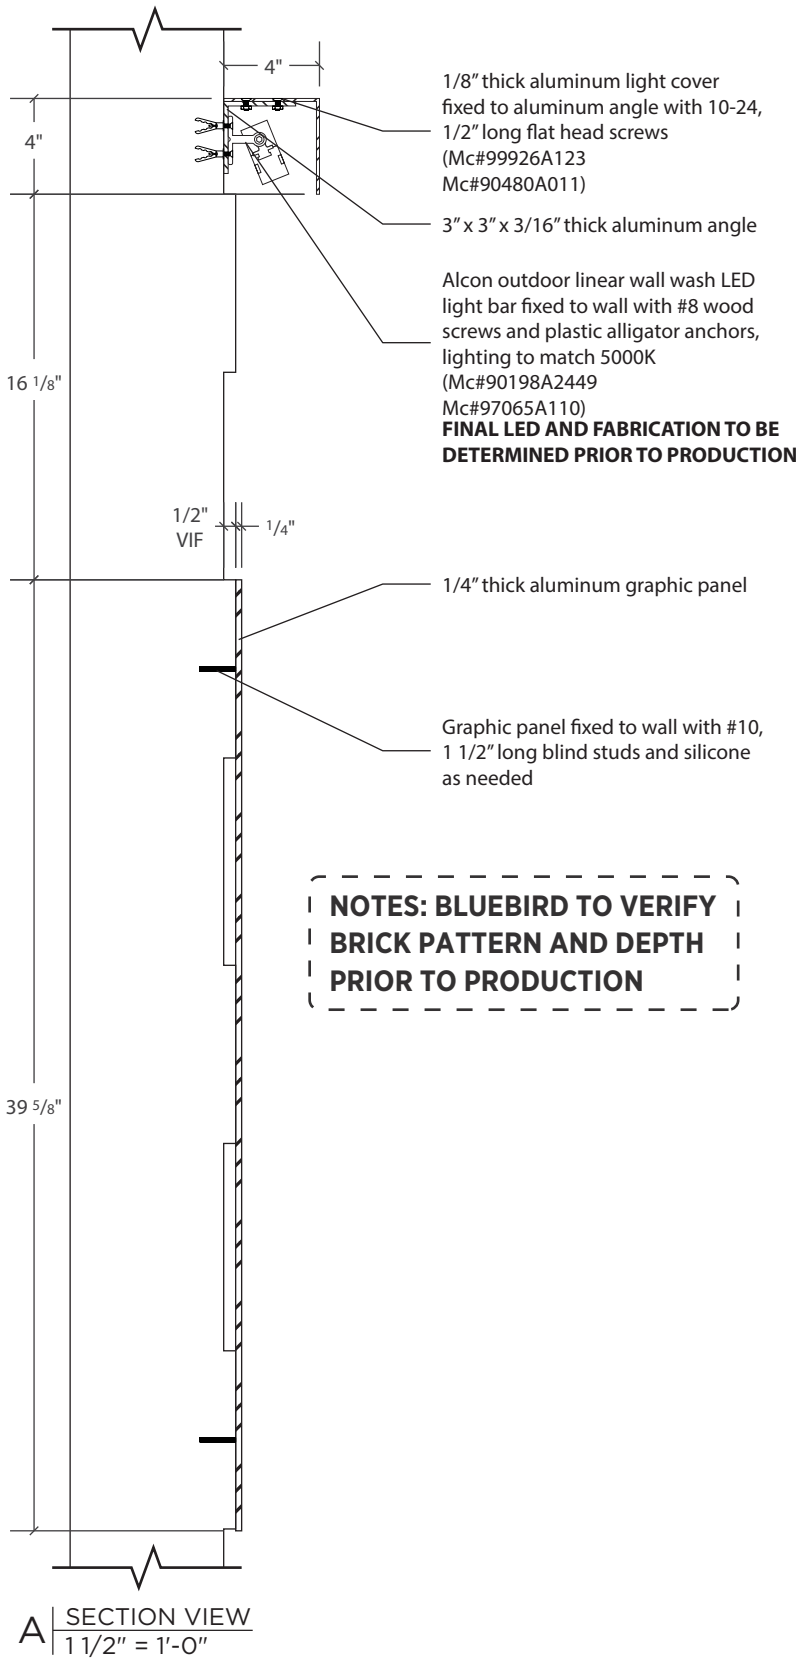

BLUEBIRD
GRAPHIC SOLUTIONS

17 Everberg Road, Unit E
Woburn, MA 01801

info@bluebirdgs.com
617.250.8500

CLIENT
ANIMAL RESCUE LEAGUE

ADDRESS
10 CHANDLER ST
BOSTON, MA 02116

PROJECT
EXTERIOR LETTERS

JOB #
PROJ-25.01763.01

SUBMISSION DATE
06/04/2025

REVISION DATE
MM/DD/YYYY

DESIGNER: K. WHITE
PM: A. MORRISON

SIGN TYPE	DRAWING
E	5.1



BLUEBIRD
GRAPHIC SOLUTIONS

17 Everberg Road, Unit E
Woburn, MA 01801

info@bluebirdgs.com
617.250.8500

CLIENT
ANIMAL RESCUE LEAGUE

ADDRESS
10 CHANDLER ST
BOSTON, MA 02116

PROJECT
EXTERIOR LETTERS

JOB #
PROJ-25.01763.01

SUBMISSION DATE
06/04/2025

REVISION DATE
MM/DD/YYYY



01 | DAY VIEW RENDERING
NTS




02 | NIGHT VIEW RENDERING
NTS

DESIGNER: K. WHITE
PM: A. MORRISON


SIGN TYPE	DRAWING
E	5.2



01 FRONT VIEW
1 1/2" = 1'-0"

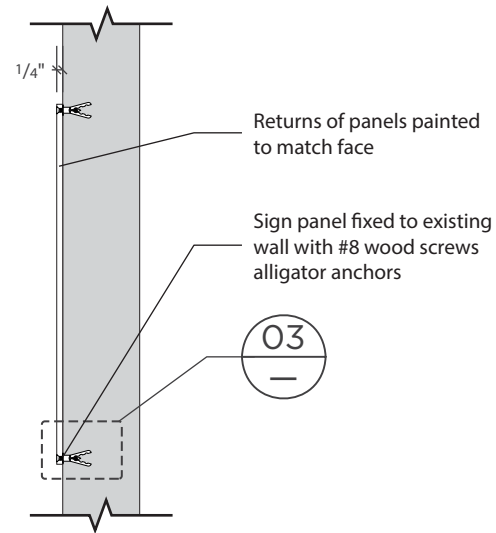

02 SIDE VIEW
1 1/2" = 1'-0"

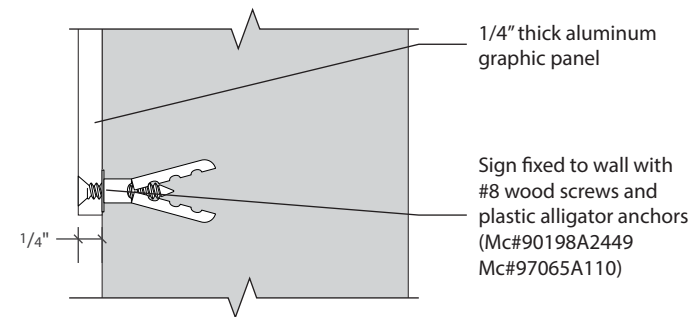


03 MOUNTING DETAIL
6" = 1'-0"

SIGN TYPE F - PRIVATE PROPERTY SIGN

Quantity (2)

PALETTE

- PAINT: TO MATCH 120 WHITE
- PRINT: TO MATCH CARDINAL RED (PMS 485C)

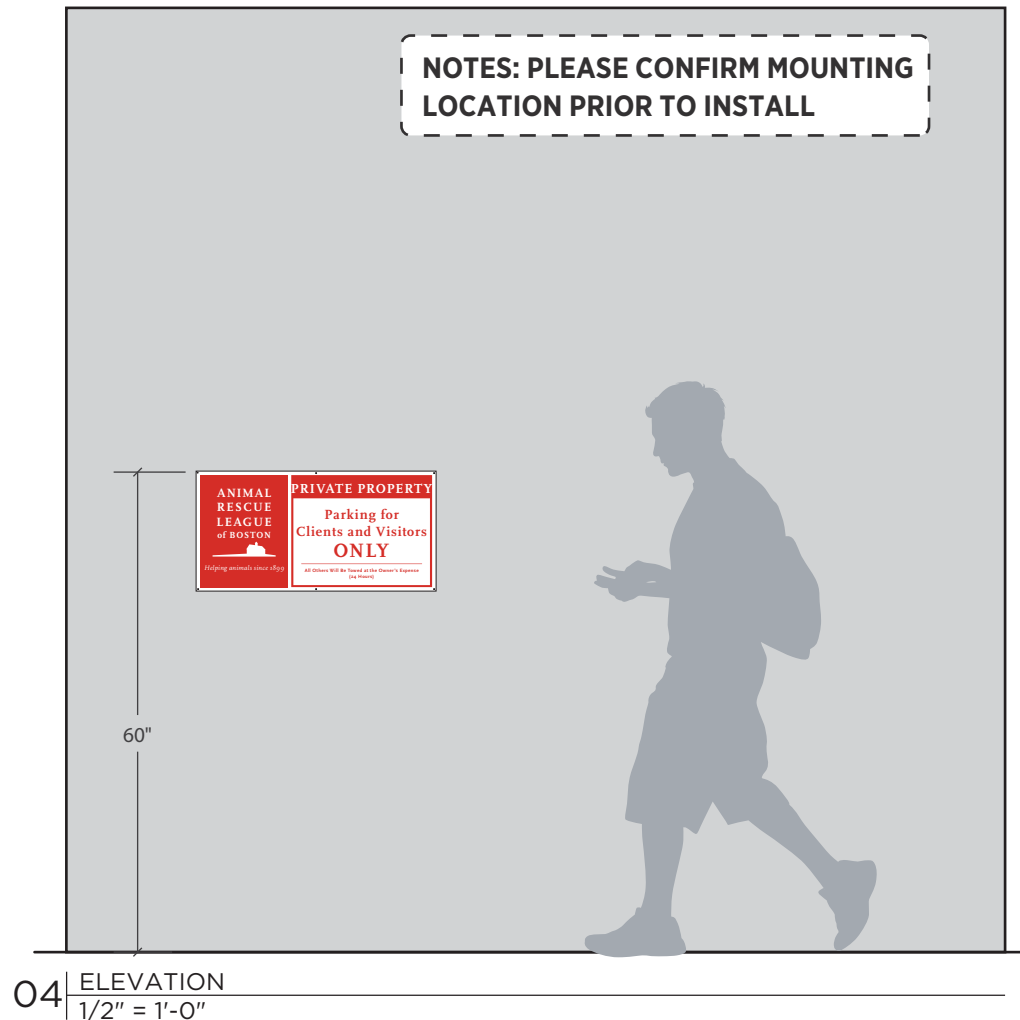

04 ELEVATION
1 1/2" = 1'-0"



BLUEBIRD
GRAPHIC SOLUTIONS

17 Everberg Road, Unit E
Woburn, MA 01801

info@bluebirdgs.com
617.250.8500

CLIENT
ANIMAL RESCUE LEAGUE

ADDRESS
10 CHANDLER ST
BOSTON, MA 02116

PROJECT
EXTERIOR LETTERS


JOB #
PROJ-25.01763.01

SUBMISSION DATE
06/04/2025

REVISION DATE
MM/DD/YYYY

DESIGNER: K. WHITE
PM: A. MORRISON

SIGN TYPE	DRAWING
F	6.0

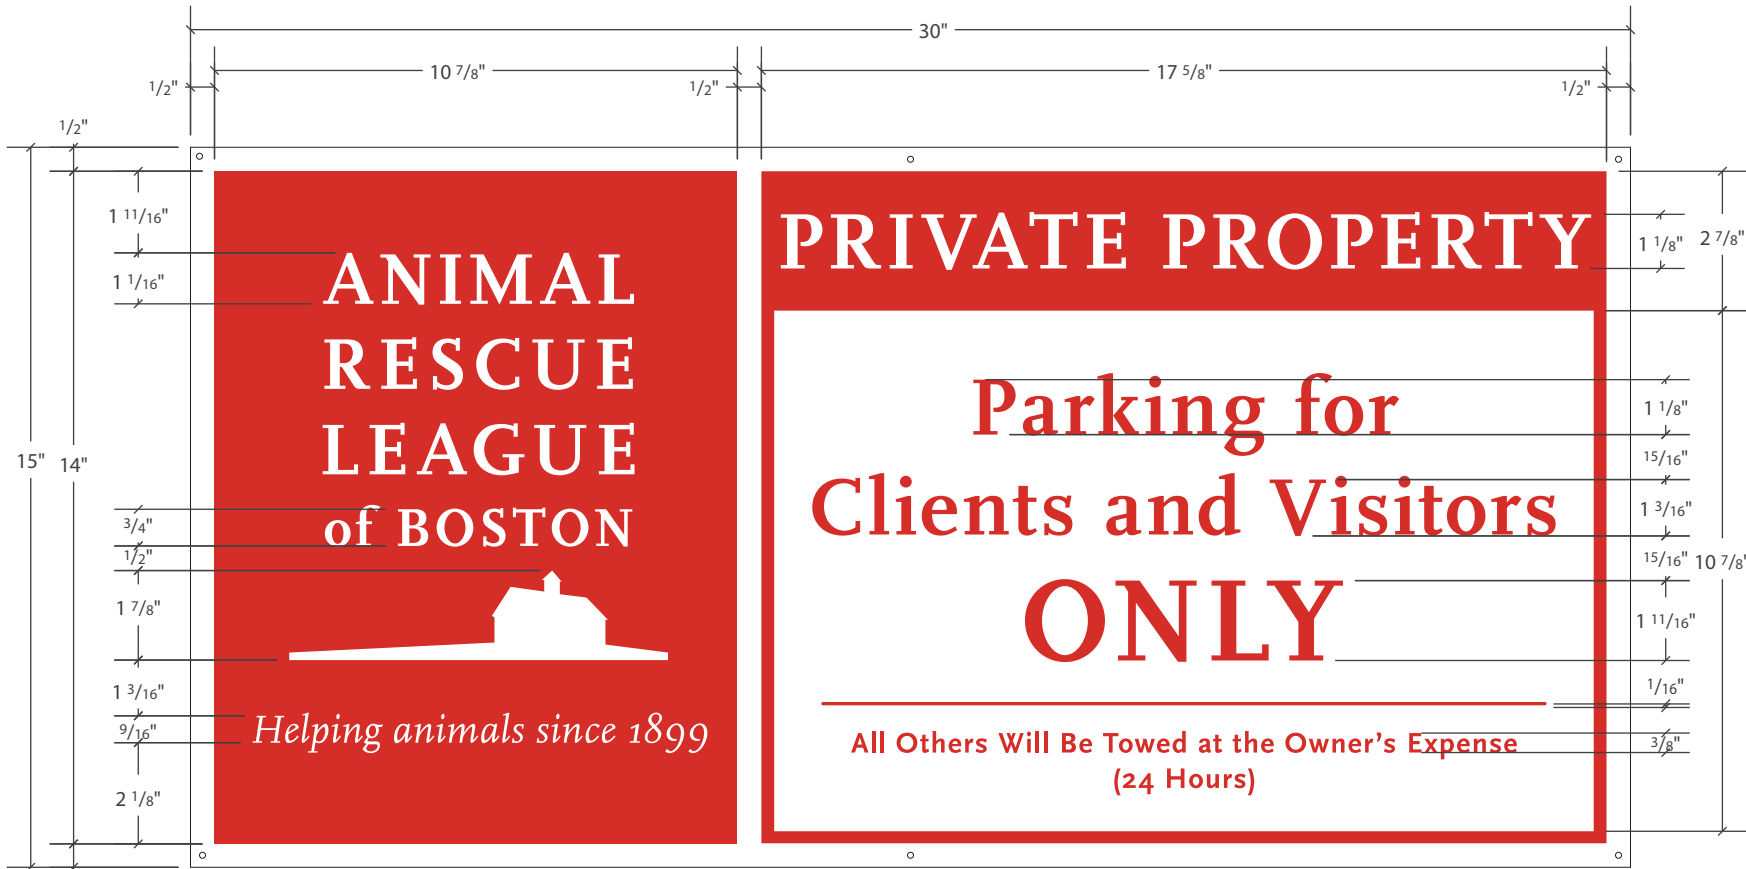

01 | GRAPHIC LAYOUT
3" = 1'-0"



BLUEBIRD
GRAPHIC SOLUTIONS

17 Everberg Road, Unit E
Woburn, MA 01801

info@bluebirdgs.com
617.250.8500

CLIENT
ANIMAL RESCUE LEAGUE

ADDRESS
10 CHANDLER ST
BOSTON, MA 02116

PROJECT
EXTERIOR LETTERS

JOB #
PROJ-25.01763.01

SUBMISSION DATE
06/04/2025

REVISION DATE
MM/DD/YYYY

DESIGNER: K. WHITE
PM: A. MORRISON

SIGN TYPE	DRAWING
F	6.1